


MARK	DESCRIPTION
A EXIT	Lighted exit sign
B EXIT	Lighted exit sign with emergency pack
C	Lighted emergency pack
D	Wall mounted incandescent light
E	50' x 50' T5 6-50W tube fluorescent.

MARK	DESCRIPTION
A EXIT	Lighted exit sign
B EXIT	Lighted exit sign with emergency pack
C	Lighted emergency pack
D	Wall mounted incandescent light
E	50' x 50' T5 6-50W tube fluorescent.

MARK	DESCRIPTION
7-7	Service panel box number - breaker space
⊖	20 amp Receptacle
E	Pull station - Top of 4' sq box, 42" above finished floor.
E	Horn Stroke - Top of 4' sq box 80" above finished floor.
PC	Protective Cover

HVAC LEGEND	
	SUPPLY AIR DIFFUSER
	RETURN AIR GRILLE
	THERMOSTAT
	DUCT SIZE
	CHANGE IN DUCT SIZE
	SUPPLY DUCT
	RETURN DUCT

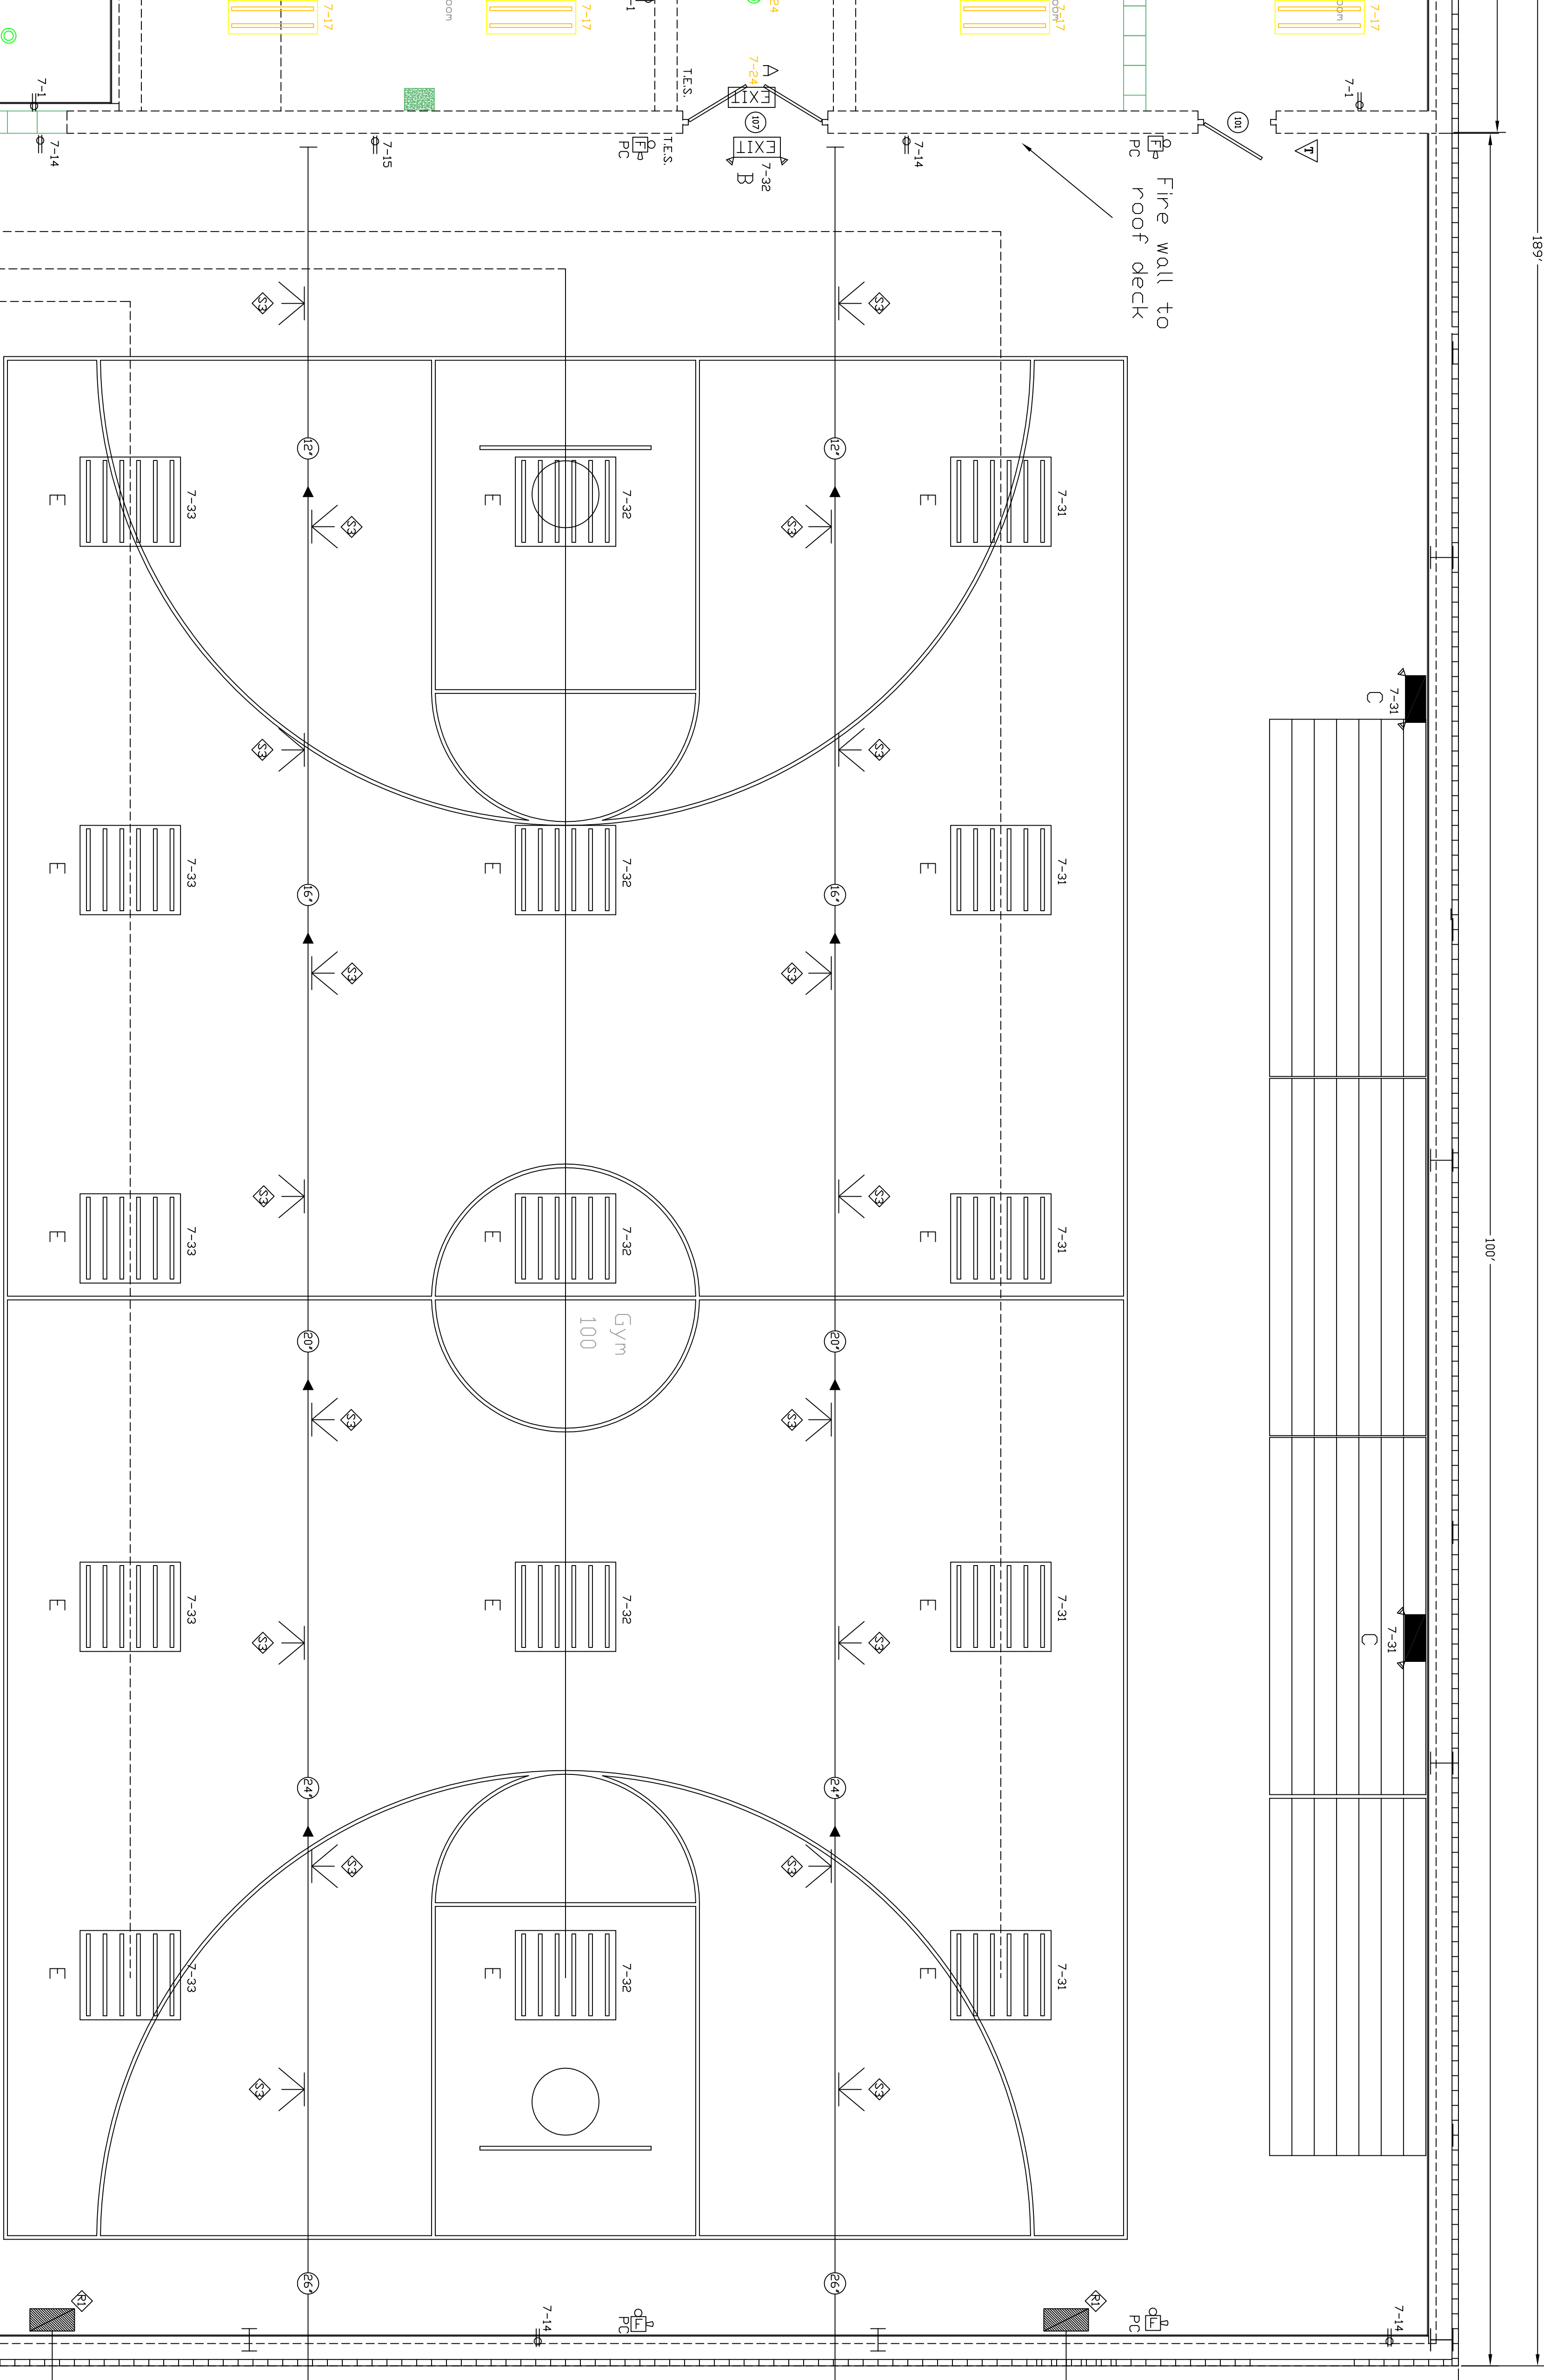

NO.	Manuf./Model	SIZE	C.F.M.	Remarks
SS	Hart & Cooley VHD (or equiv.)	24 X 10	525	Two rows of individual adjustable face bars for horizontal & vertical deflection / Opposed blade damper
BI	Hart & Cooley RCB	48 X 30	4,500	Extended aluminum construction

Unit #	Manuf. & Model #	Output	Volt	AMPS/MAX	Remarks
PKG-1	Traue / THH150P3R0A	c 14000	208/230	65/80	Locate on contractor supplied concrete pad
PKG-2	Traue / THH150P3R0A	c 14000	208/230	65/80	Locate on contractor supplied concrete pad

SCALE: 1/4" = 1' 0"

S
N
E
W

PENN VIEW BIBLE INSTITUTE
P. O. BOX 970 PENNS CREEK, PA. 17862
PHONE: 837 1855

M & M BUILDING CONSTRUCTION

DESIGN BY
STEVE WITMER
Phone (570) 374-5760

This drawing is an instrument of service. It is and shall remain the property of Steve Witmer.

Information contained in these drawings are for code compliant drawings and building code approval only. Steve Witmer accepts no responsibility for the adequacy of information and designs provided by other parties.

**Gymnasium
Layout
Lighting
&
Power**

SYN: DRAWN BY:
SDW

DESIGN BY: CHECKED BY:
SDW JS

DATE: 10/25/2015

PROJECT NO: 101MM

DRAWING NO.

G-101

18 OF 28 SHEETS